


Attachment 1

COUNCIL
Item No. 9.4.2
No. Pages 3

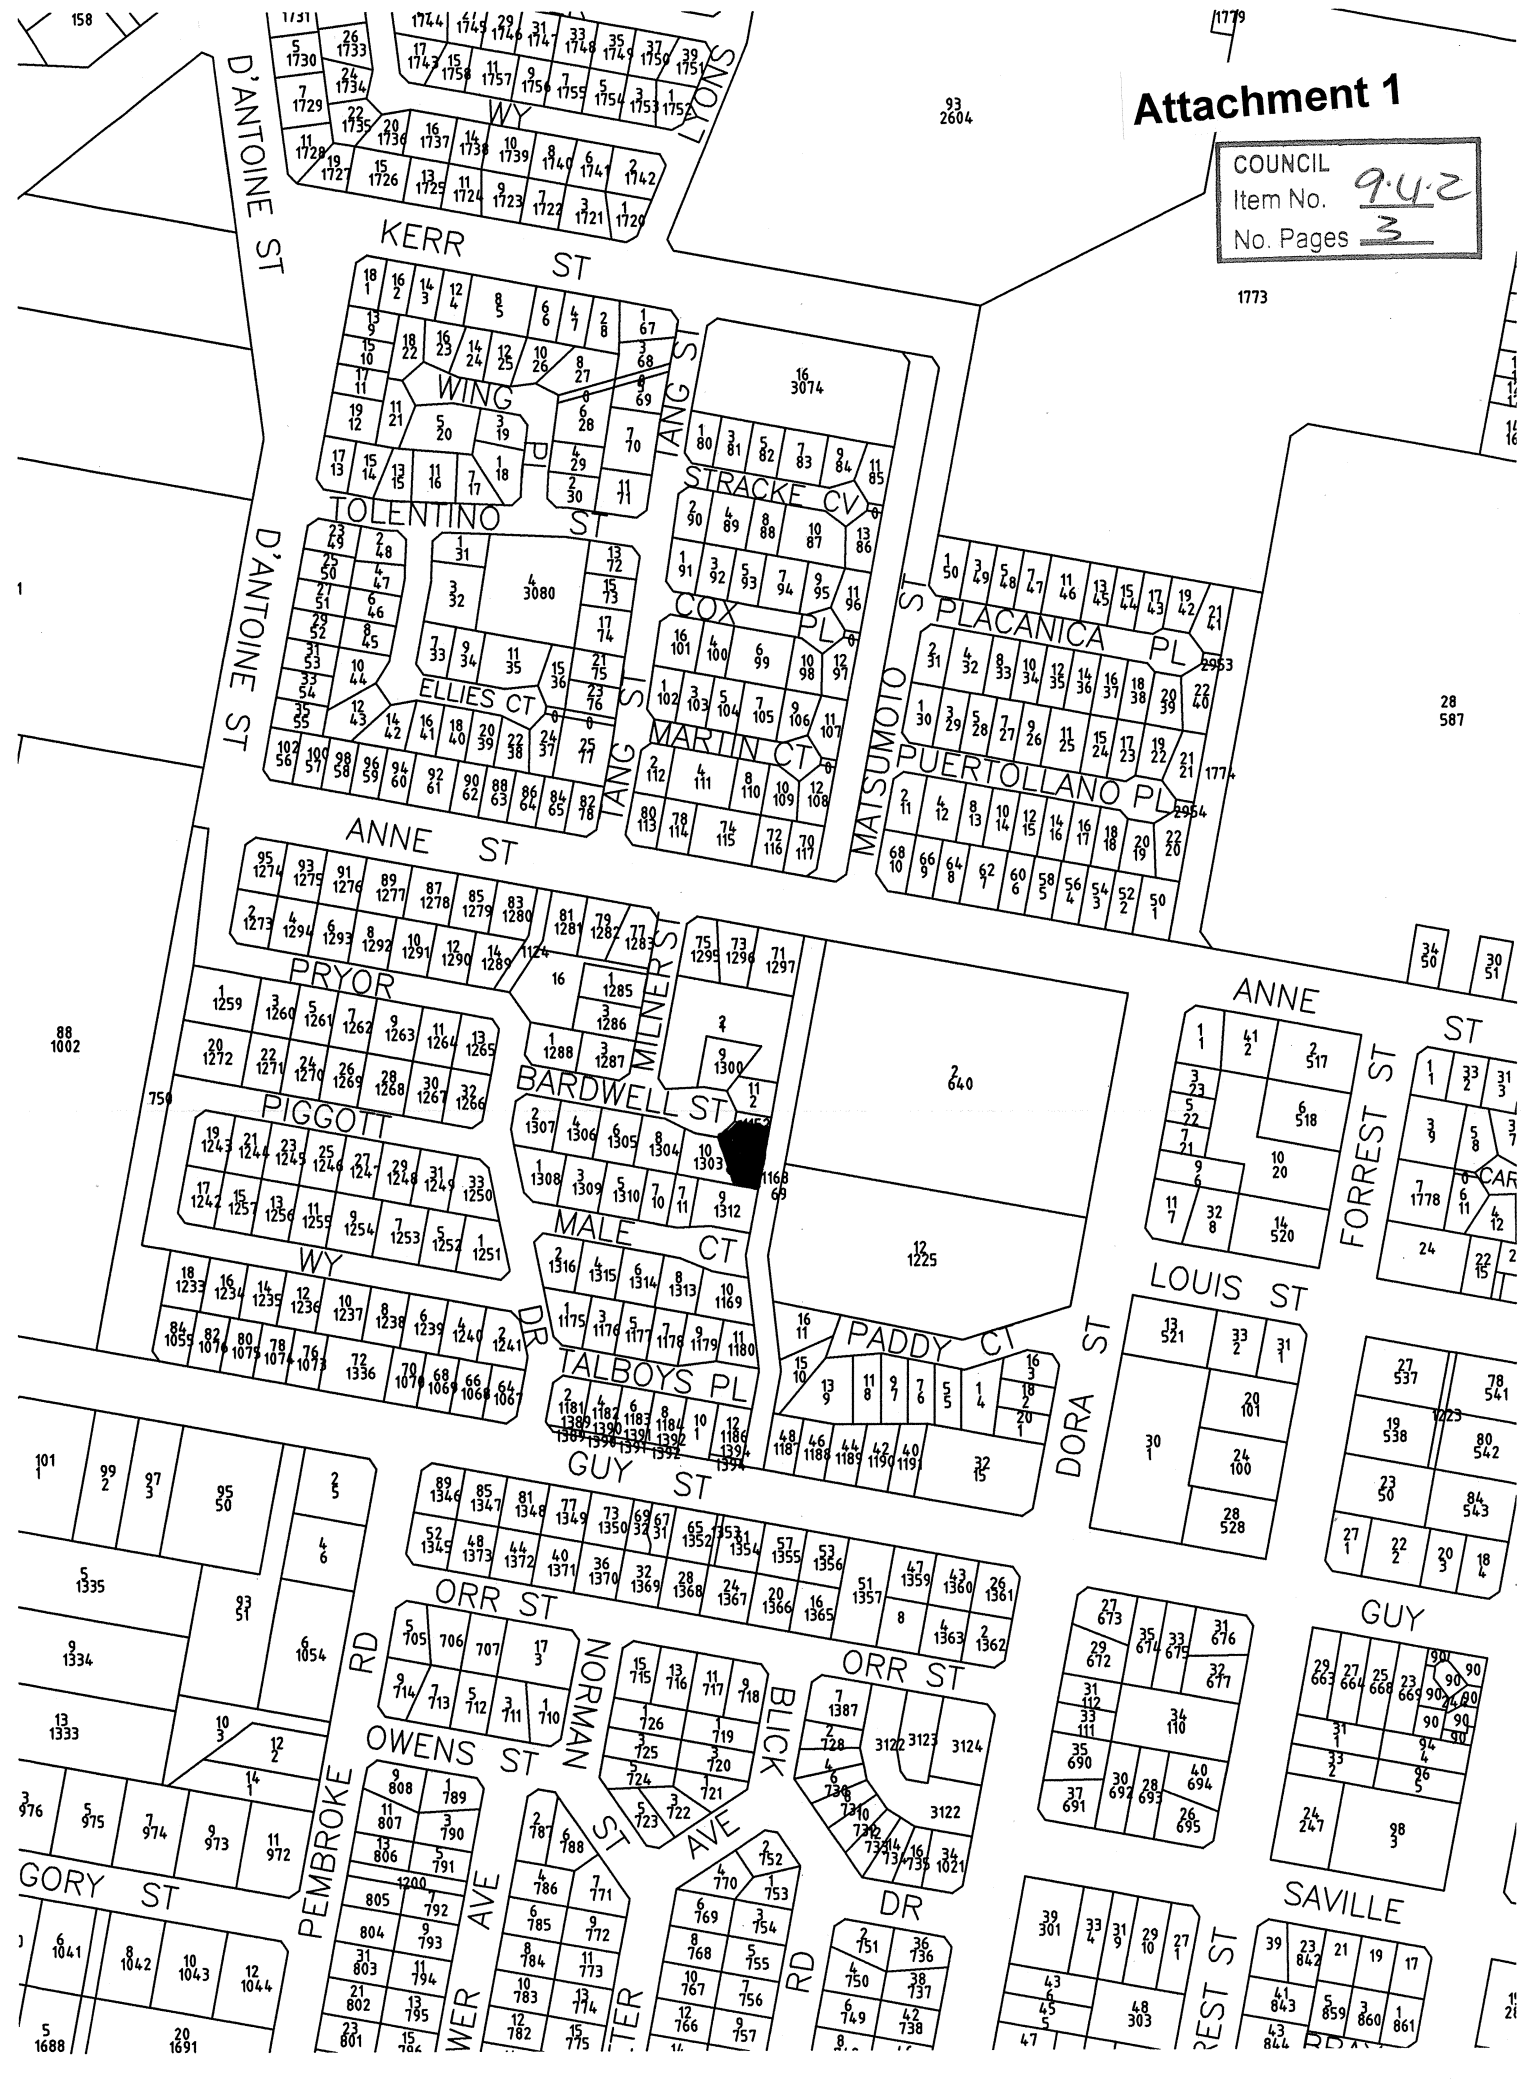

93
2604


1773

28
587

88
1002

11
21

Attachment 2

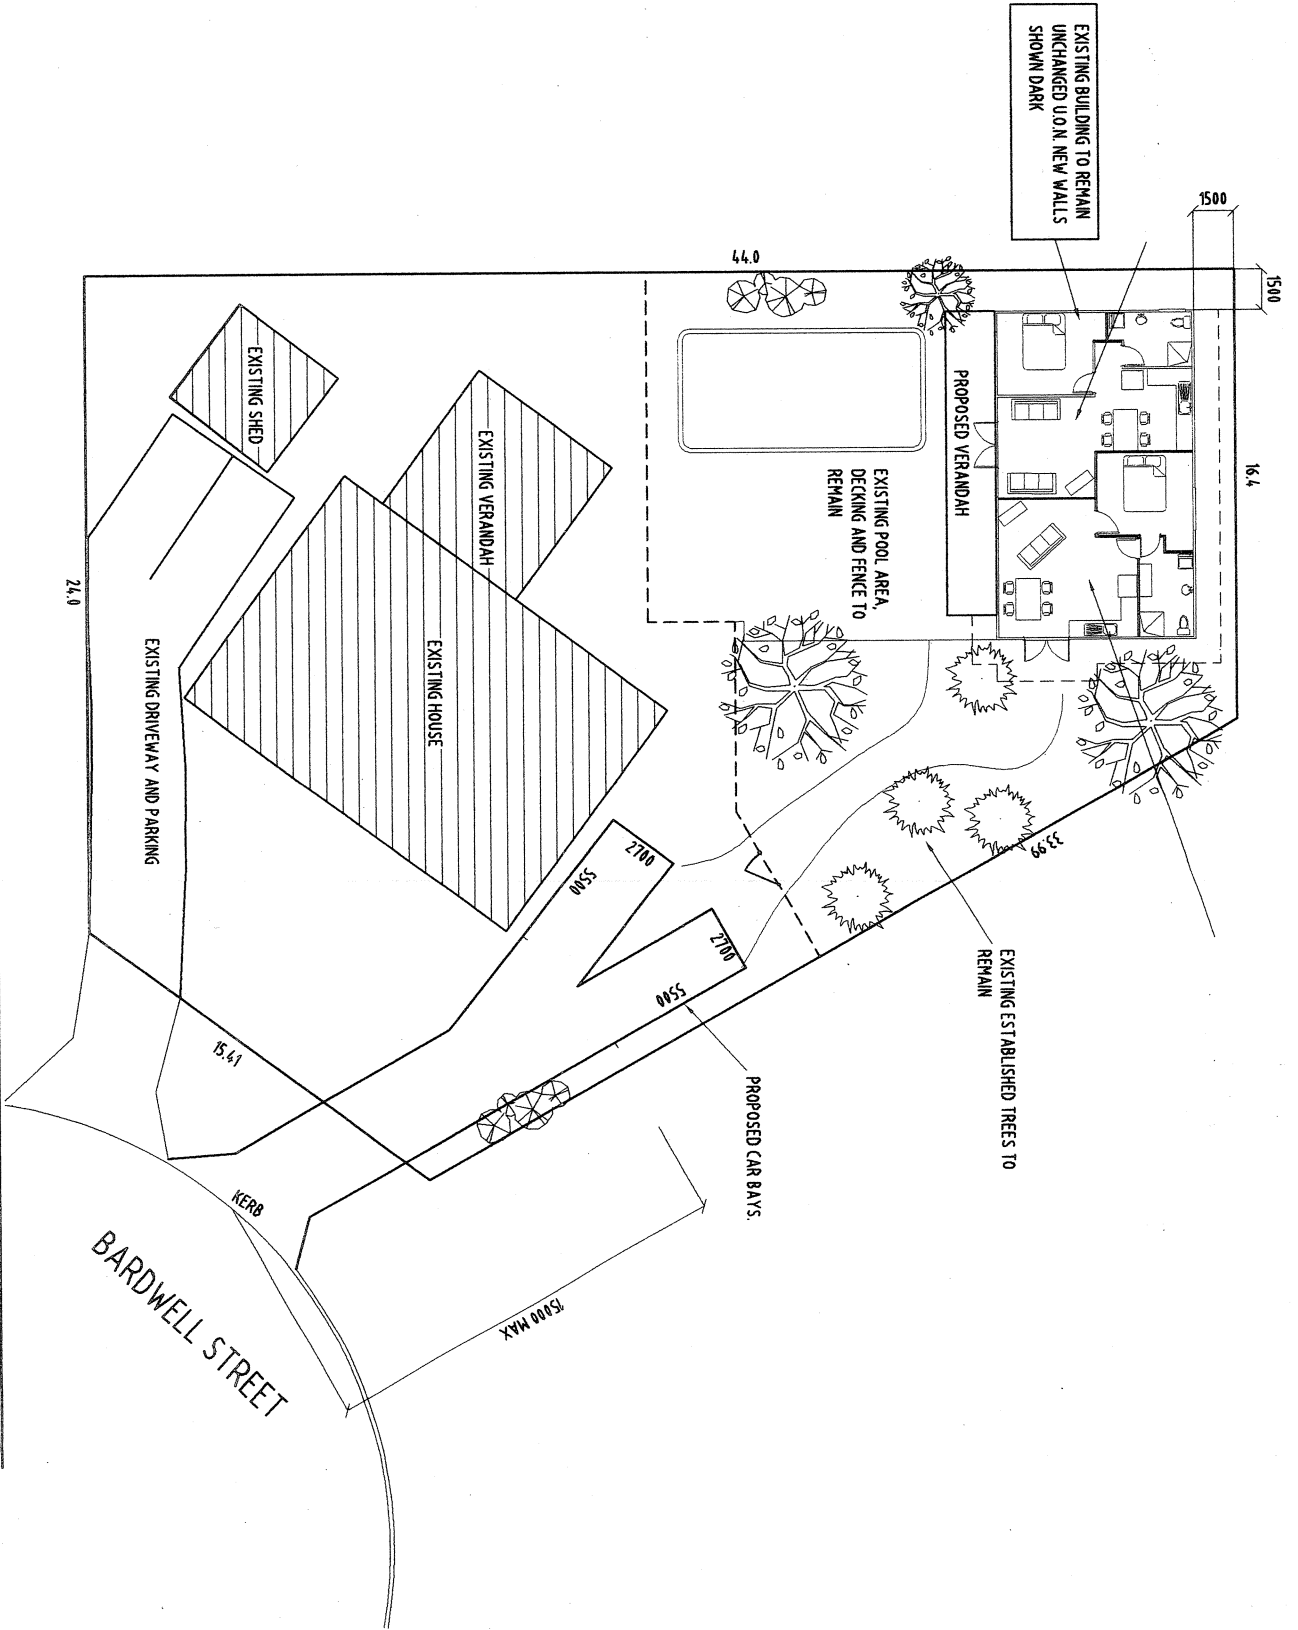


SITE PLAN


Project: PROPOSED INTERNAL WALLS AND VERANDAH
 LOT 1302, No 12 BARDWELL STREET
 BROOME

Client:	Checked:	Drawn:	Drawing No:	Rev:
Scale: 1:200	DATE 28-02-08	pdf	pdf	0201-A1

building advice
 building design
 drafting solutions
 po box 6321
 broome 6725
 p/f 08 91923169
 poster @ ipg.com.au
 m 0407089851

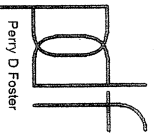


reliable
 experienced
 building consultants

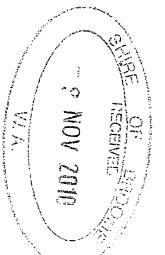

Attachment 3

ALL WINDOW
WITH SELF
SCREENS &
REGULATI

ORS TO BE EQUIPPED
WITH SELF
SECURITY
WITH POOL SAFETY

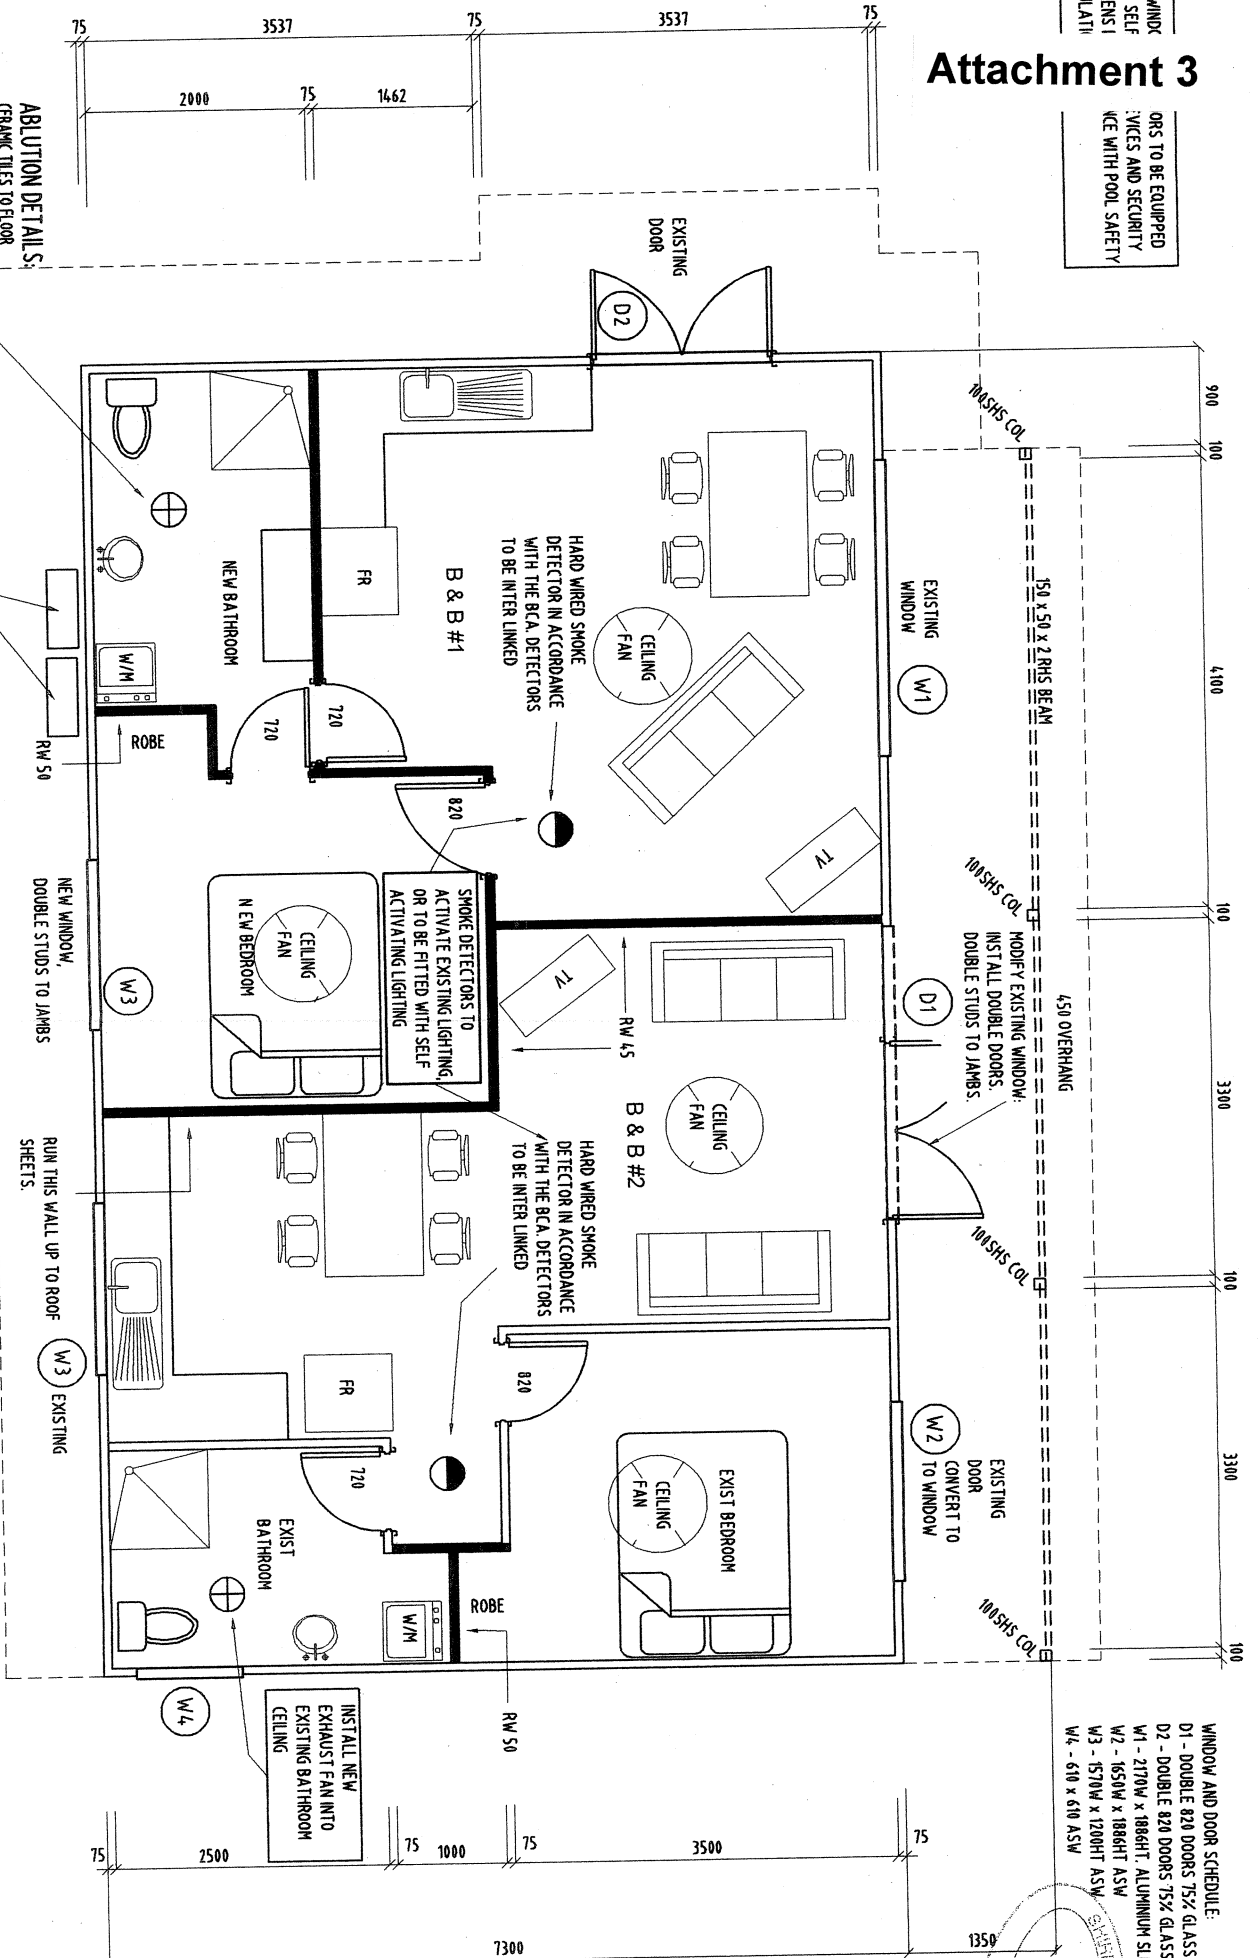

- WINDOW AND DOOR SCHEDULE:**
- D1 - DOUBLE 820 DOORS 75% GLASS
 - D2 - DOUBLE 820 DOORS 75% GLASS
 - W1 - 2170W x 1886HT ALUMINIUM SLIDING WINDOW
 - W2 - 1650W x 1886HT ASW
 - W3 - 1570W x 1200HT ASW
 - W4 - 610 x 610 ASW

NOV 2010

ABLUTION DETAILS:
CERAMIC TILES TO FLOOR
1 ROW SKIRTING TILES
1 ROW TILES ABOVE BASINS
TILED BRICK HOOD TO SHOWER
FALLS TO FLOOR WASTES PROVIDED BY
SCORED TO TILES
WILLBOARD WALL LINING
PLASTERBOARD CEILING
EXHAUST FAN INSTALLED IN CEILING
ALL WATER PROOFING TO CONFORM
WITH THE B.C.A.

HARD WIRED SMOKE
DETECTOR IN ACCORDANCE
WITH THE BCA DETECTORS
TO BE INTER LINKED

SMOKE DETECTORS TO
ACTIVATE EXISTING LIGHTING
OR TO BE FITTED WITH SELF
ACTIVATING LIGHTING

HARD WIRED SMOKE
DETECTOR IN ACCORDANCE
WITH THE BCA DETECTORS
TO BE INTER LINKED

INSTALL NEW
EXHAUST FAN INTO
EXISTING BATHROOM
CEILING

INVERTER TYPE SPLIT SYSTEM AIR
CONDITIONERS INSTALLED IN ACCORDANCE
WITH B.C.A. 3.12.5.3, LOCATION INDICATIVE
ONLY

REV 'A' EXHAUST FAN AND SMOKE ALARM NOTES ADDED pdf 03-04-08

Project: **PROPOSED INTERNAL WALLS AND VERANDAH**
LOT 1302, No 12 BARDWELL STREET
BROOME

Client: _____

Scale: 1:50

DATE 28-02-08


Checked: pdf

Drawn: pdf

Drawing No: 0201-A2

Rev: A

building advice
building design
drafting solutions
po box 6325
broome 6125
ph 08 91923189
poster@pqs.com.au
m 0407089851

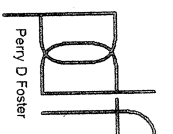

reliable
experienced
building consultants